


CROSLEY STATE FISH & WILDLIFE AREA

OFFICE REMODELING

JENNINGS COUNTY

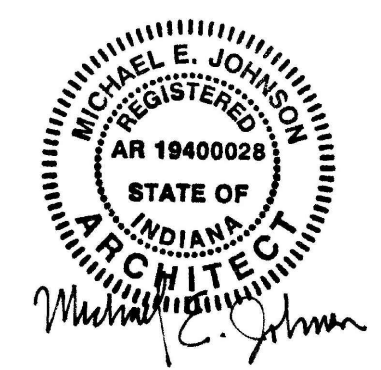

Certified by:

LOCATION MAP



PROJECT LOCATION
NORTH VERNON
JENNINGS COUNTY, IN

DRAWINGS INDEX

GENERAL

- G-1 DRAWINGS INDEX, LOCATION MAP
- G-2 SCOPE OF WORK, SPECIFICATIONS

CIVIL ENGINEERING - ALTERNATE #1

- C-1 SITE PLAN, ALTERNATE #1 - DETAILS

ARCHITECTURAL - BASE BID

- A-1 DEMOLITION PLAN, FLOOR PLAN, FINISH SCHEDULE, WALL TYPES.
- A-2 PARTIAL FLOOR PLAN, DETAILS.
- A-3 DOOR SCHEDULE, DETAILS.
- A-4 INTERIOR ELEVATIONS, DETAILS.

STRUCTURAL - ALTERNATE #2

- S-1 PORCH STRUCTURE UPDATE.

PLUMBING - BASE BID

- P-1 PLUMBING FLOOR PLAN & SCHEDULE, & ISOMETRICS

ELECTRICAL - BASE BID

- E-1 LIGHTS & RECEPTACLES SCHEDULE

PROJECT INFORMATION

BUILDING ADDRESS: CROSLEY STATE FISH & WILDLIFE AREA
North Vernon, IN 47265-7950
(219) 928-3997

COUNTY: Jennings

OCCUPANCY TYPE: B

CONSTRUCTION TYPE: TYPE VB
INDIANA BUILDING CODE 2014 EDITION

ZONING AUTHORITIES: N/A

BUILDING DESCRIPTION: EXISTING BUILDING REMODEL

BUILD-OUT AREA: EXISTING: 1224 S.F. (gross)
PORCH: 370 S.F. (gross)
ADDITION: 0 S.F.

OCCUPANT LOAD: 8 PEOPLE


APPLICABLE CODES:
GENERAL ADMINISTRATIVE RULES (GAR) 675 IAC 12
2014 INDIANA BUILDING CODE (2012 INTERNATIONAL BUILDING CODE) 675 IAC 13-2.3
2014 INDIANA MECHANICAL CODE (2012 IMC) 675 IAC 18-1.4
2012 INDIANA PLUMBING CODE 675 IPC IAC 16-1.3
2009 INDIANA ELECTRICAL CODE (NFPA 70-2008) 675 IAC 17-1.8
2010 INDIANA ENERGY CONSERVATION CODE (ASRAE 90.1, 2007 EDITION AS AMENDED) 675 IAC 19
2014 INDIANA FIRE CODE, 2014 (IFC 2012 NFPA 13 AND 13R (2010 EDITION))

ENERGY COMPLIANCE R-VALUE INFORMATION FOR HEATED BLDG. PARTIAL ENVELOPE DATA:

CLIMATE ZONE 4		
WALLS:	EXISTING 8" CMU WITH CORE-FILLED PERLITE	R-7
	EXISTING 2" EXTRUDED RIGID INSULATION	R-10
DOORS:	NEW INSULATED STEEL FRONT DOOR	U-FACTOR 0.27
ATTIC:	NEW FIBERGLASS BATT INSULATION	R-38
WINDOWS:	EXISTING ALUMINUM CLAD WOOD; W/INSULATED GLASS(ARGON)	U-FACTOR .33
FLOOR SLAB:	EXISTING	R-15 FOR 24"


NOTE:
BUILDING BUILT IN 1959.
675 IAC 12-4-12 (j): Alterations of building built prior to January 21, 1978 need not conform with the new construction standards of 675 IAC 19.

AREA MAP

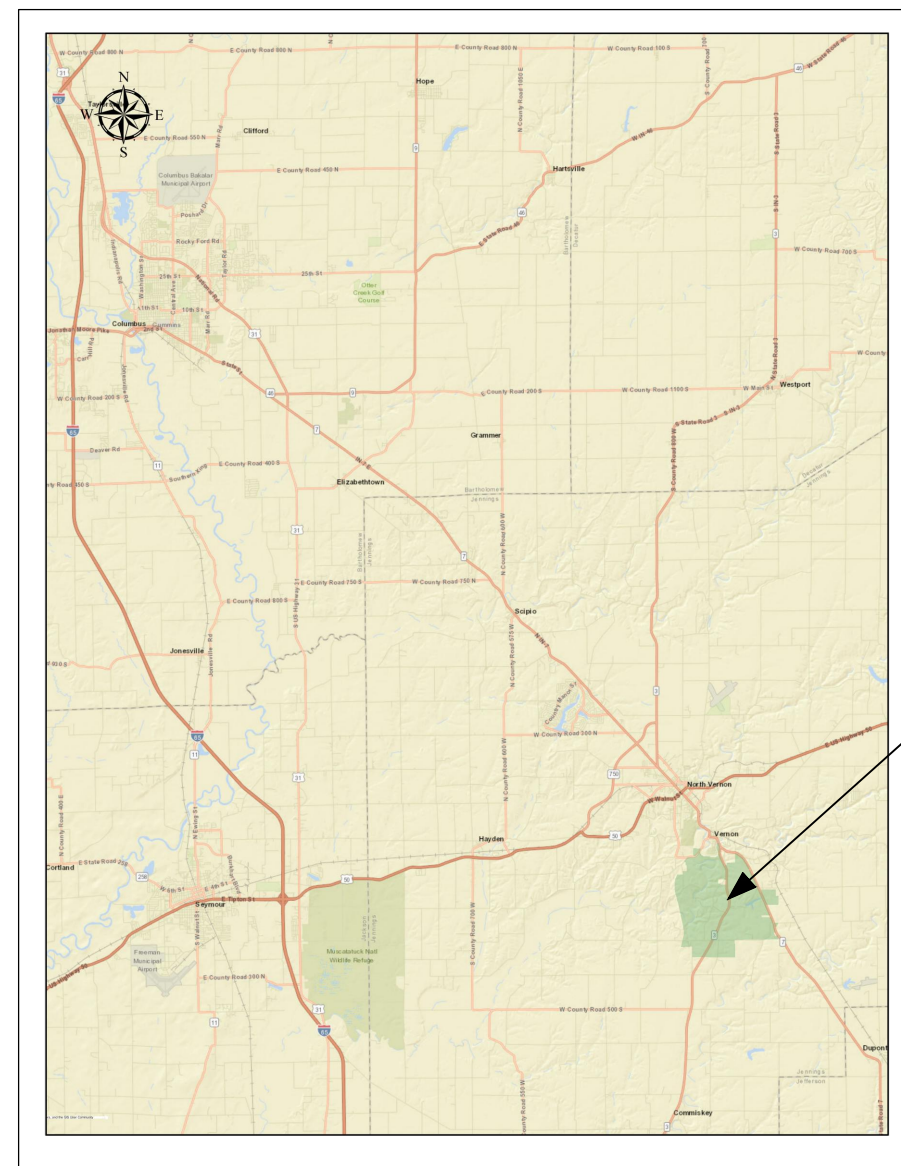


CROSLEY OFFICE LOCATION


VICINITY MAP

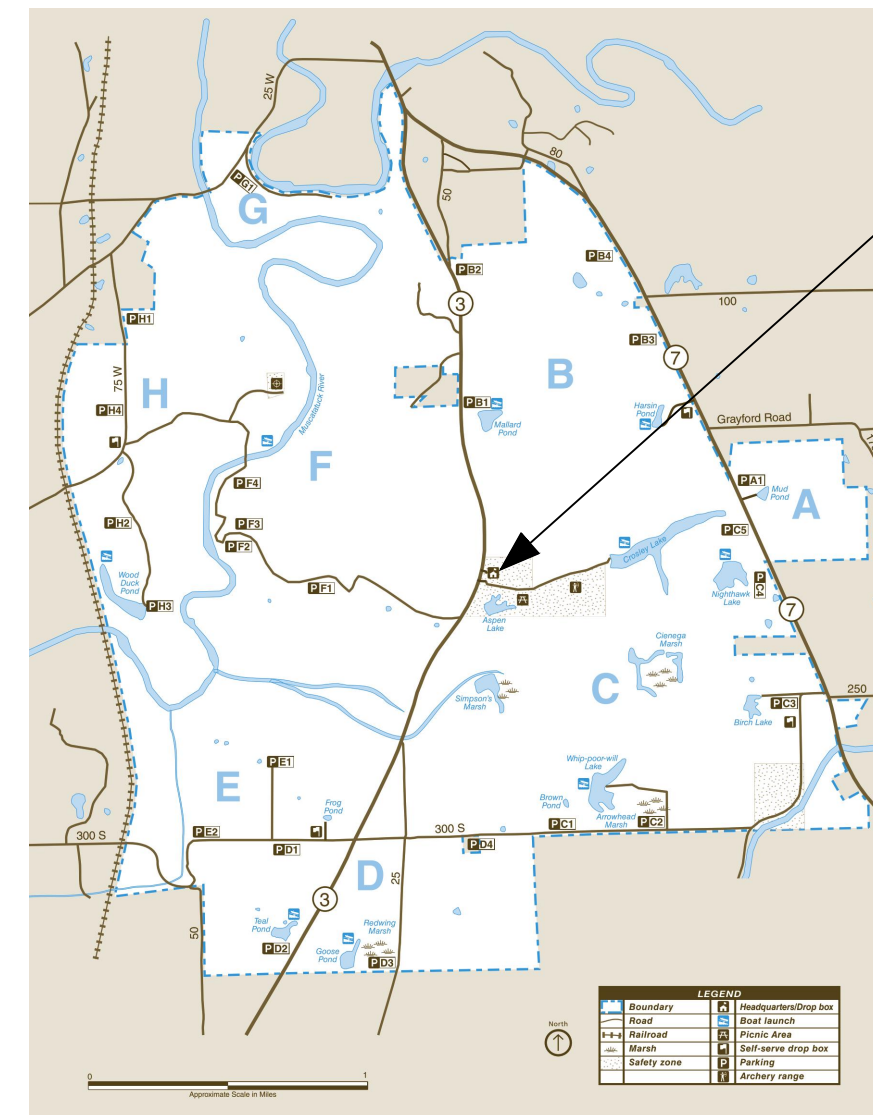

CROSLEY OFFICE LOCATION

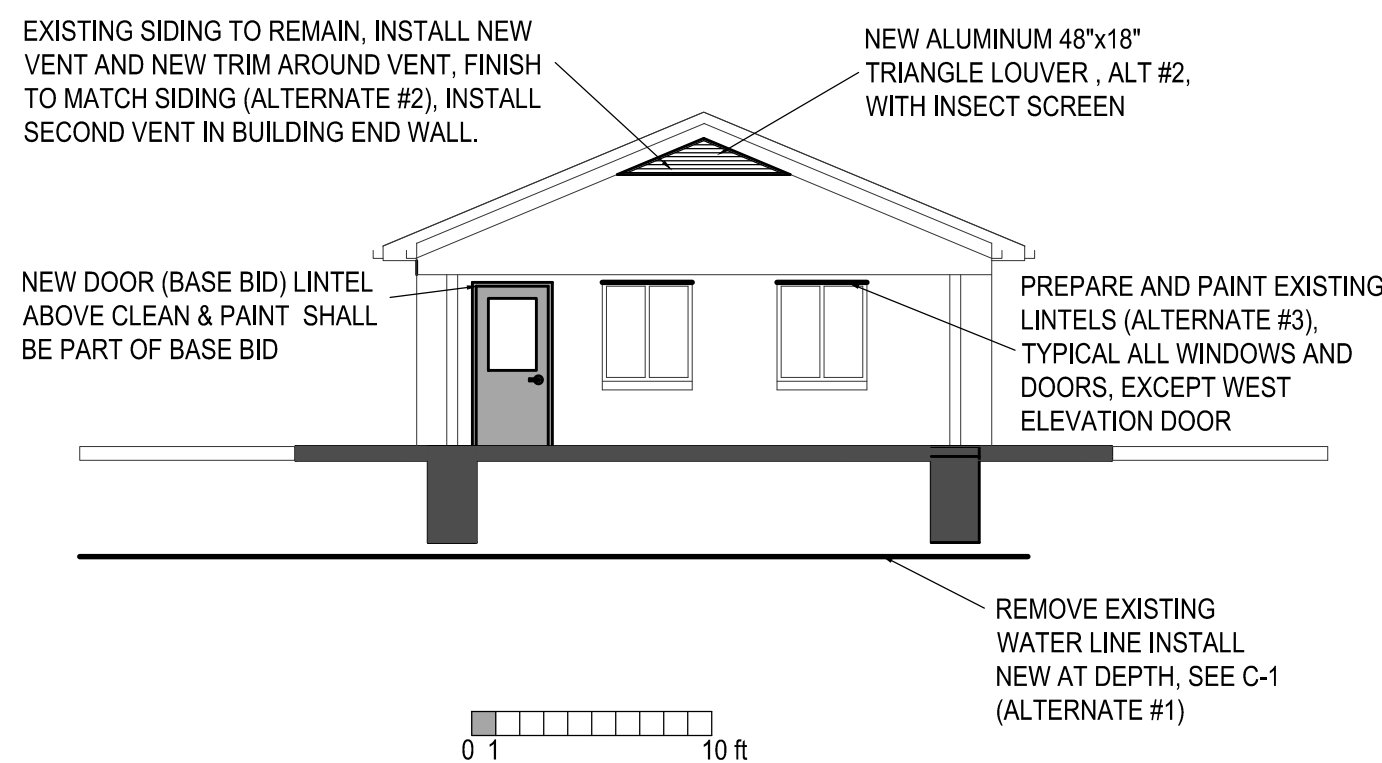


WEST ELEVATION

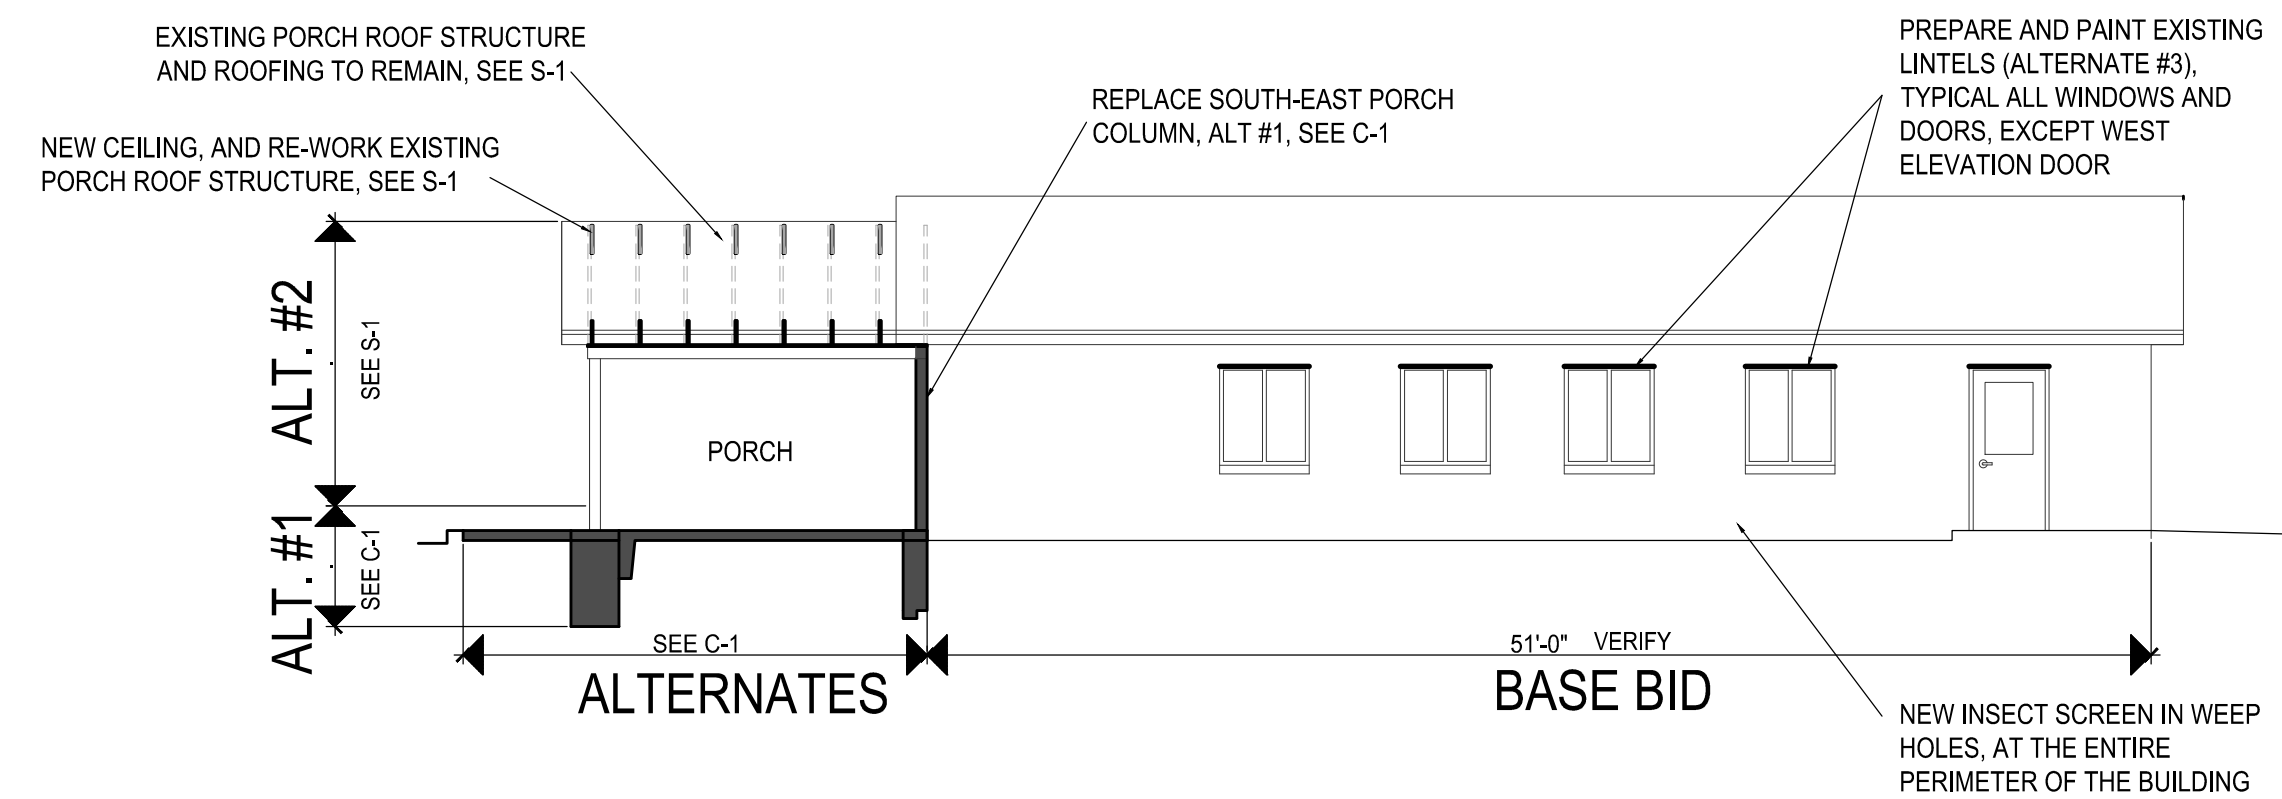

SOUTH ELEVATION

LIFE SAFETY/CODE COMPLIANCE PLAN FOR REMODELING OF OFFICE AT CROSLEY STATE FISH & WILDLIFE AREA

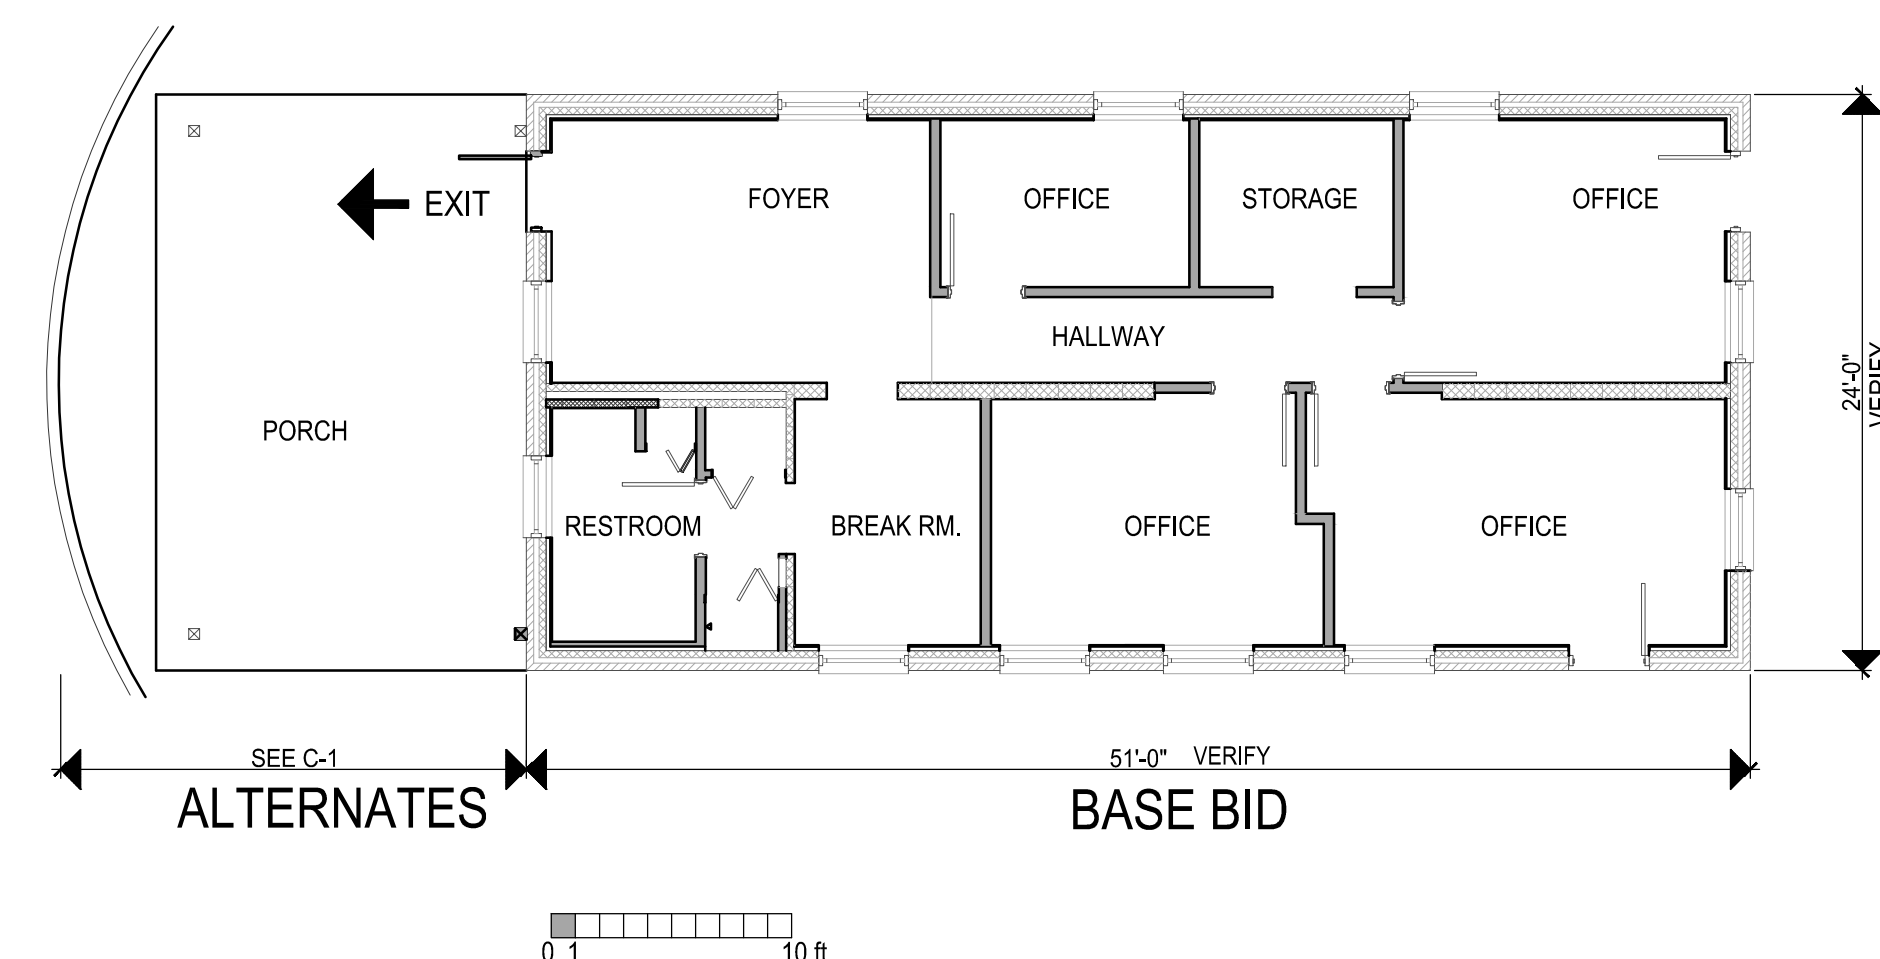

CROSLEY FISH & WILDLIFE OFFICE
 OFFICE REMODELING
 INDIANA DEPT. OF NATURAL RESOURCES
 2010 South State Road 3
 NORTH VERNON, IN 47265 - 7950



STATE OF INDIANA
 DEPARTMENT OF NATURAL RESOURCES
DIVISION OF ENGINEERING
 ROOM W209, INDIANA GOVERNMENT CENTER SOUTH
 402 WEST WASHINGTON STREET
 INDIANAPOLIS, INDIANA 46204
 TEL. 317-232-4150, FAX 317-231-1205

Revisions:	
Project Number:	ENG1902899363
Requisition Number:	102570
Designer:	B.D., M.J.
Drawing Date:	04-29-2019
Drafter:	B.D.
Drawing Scale:	AS NOTED
DNR Approval:	
Client Approval:	
File Number:	092 - 027
Drawing Number:	G - 1
Sheet:	of